




- INCANDESCENT CEILING
- INCANDESCENT WALL
- LAMPHOLDER W/ PULLCHAIN
- CEILING FAN / LIGHT
- SMOKE DETECTOR
- EXHAUST FAN
- SURFACE FLUORESCENT
- SINGLE POLE SWITCH
- THREE WAY SWITCH
- DUPLEX RECEPTACLE
- DUPLEX, WATERPROOF
- GFI DUPLEX RECEPTACLE, 44" AFF
- SPECIAL PURPOSE CONNECT
- TELEPHONE
- CABLE TELEVISION
- WATER HEATER
- PANELBOARDS
- DISCONNECT
- ELECTRICAL METER

AREAS	
HEATED & COOLED	1st FLOOR = 963 SQ.FT.
	2nd FLOOR = 1107 SQ.FT.
ENTRY PORCH	162 SQ.FT.
2 ND FLOOR PORCH	58 SQ.FT.
TOTAL	2290 SQ.FT.

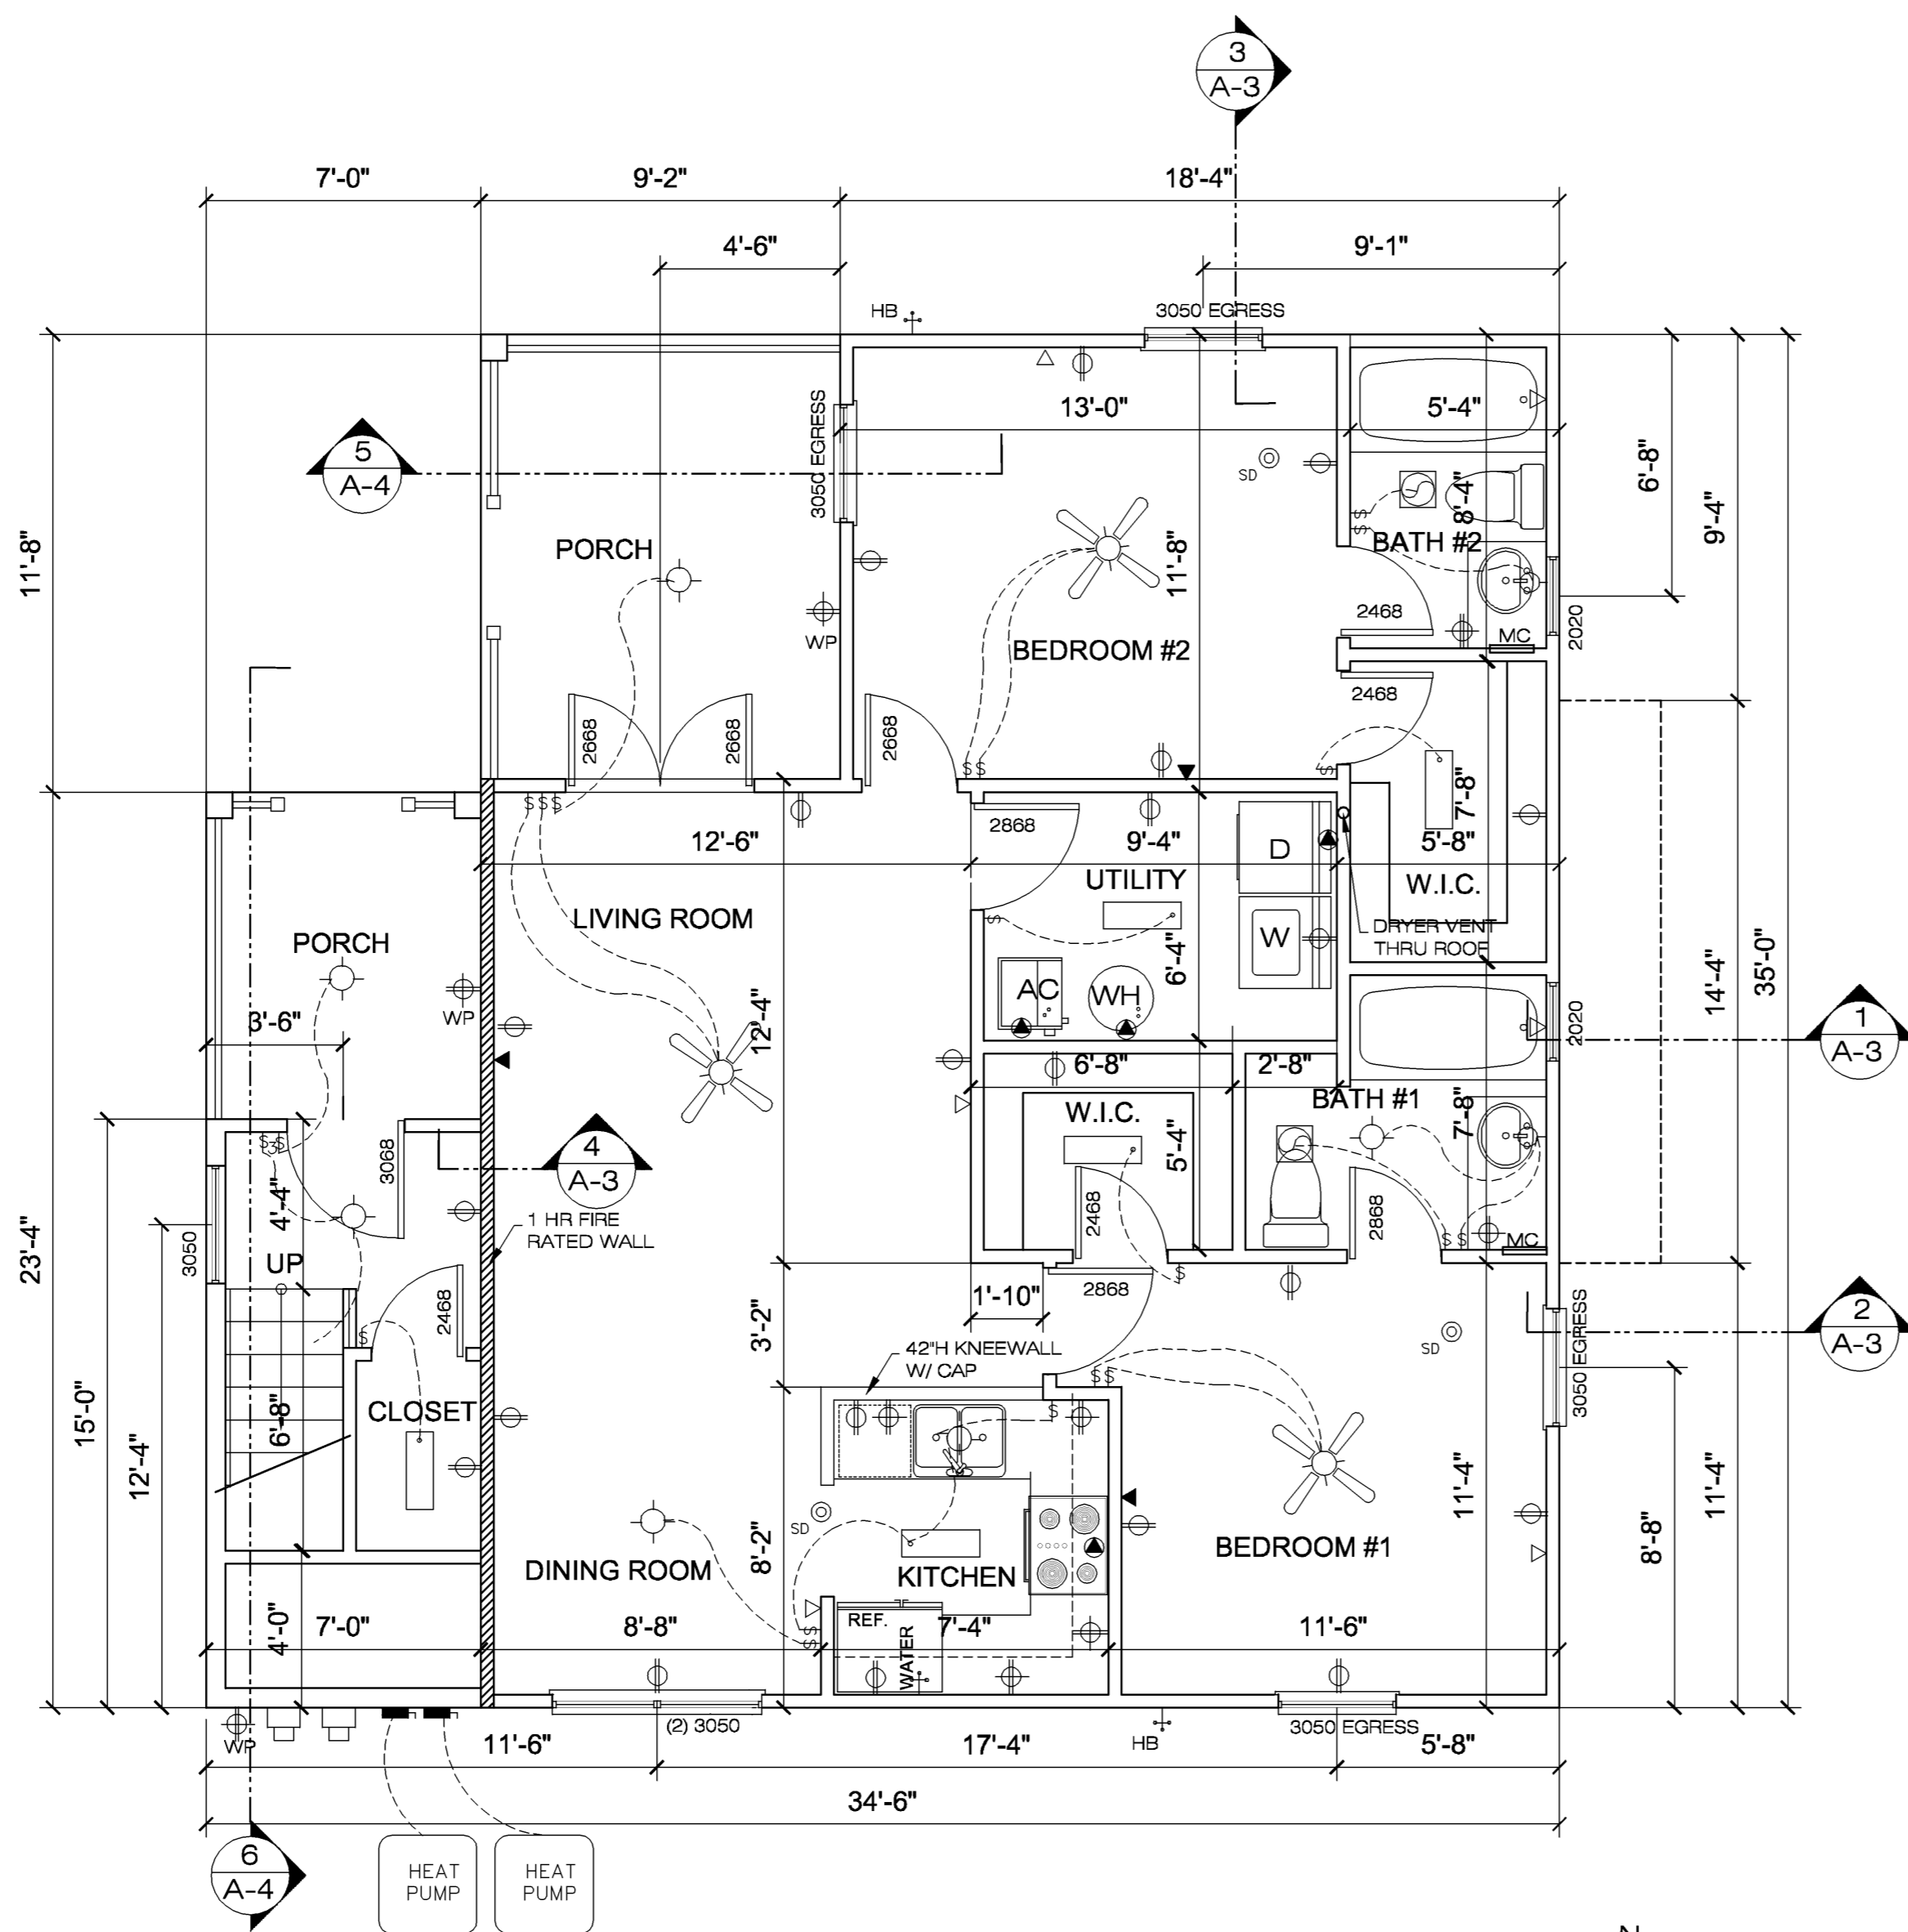

BUILDING #1 - FIRST FLOOR PLAN W/ ELECTRICAL

SCALE: 1/8" = 1'-0"

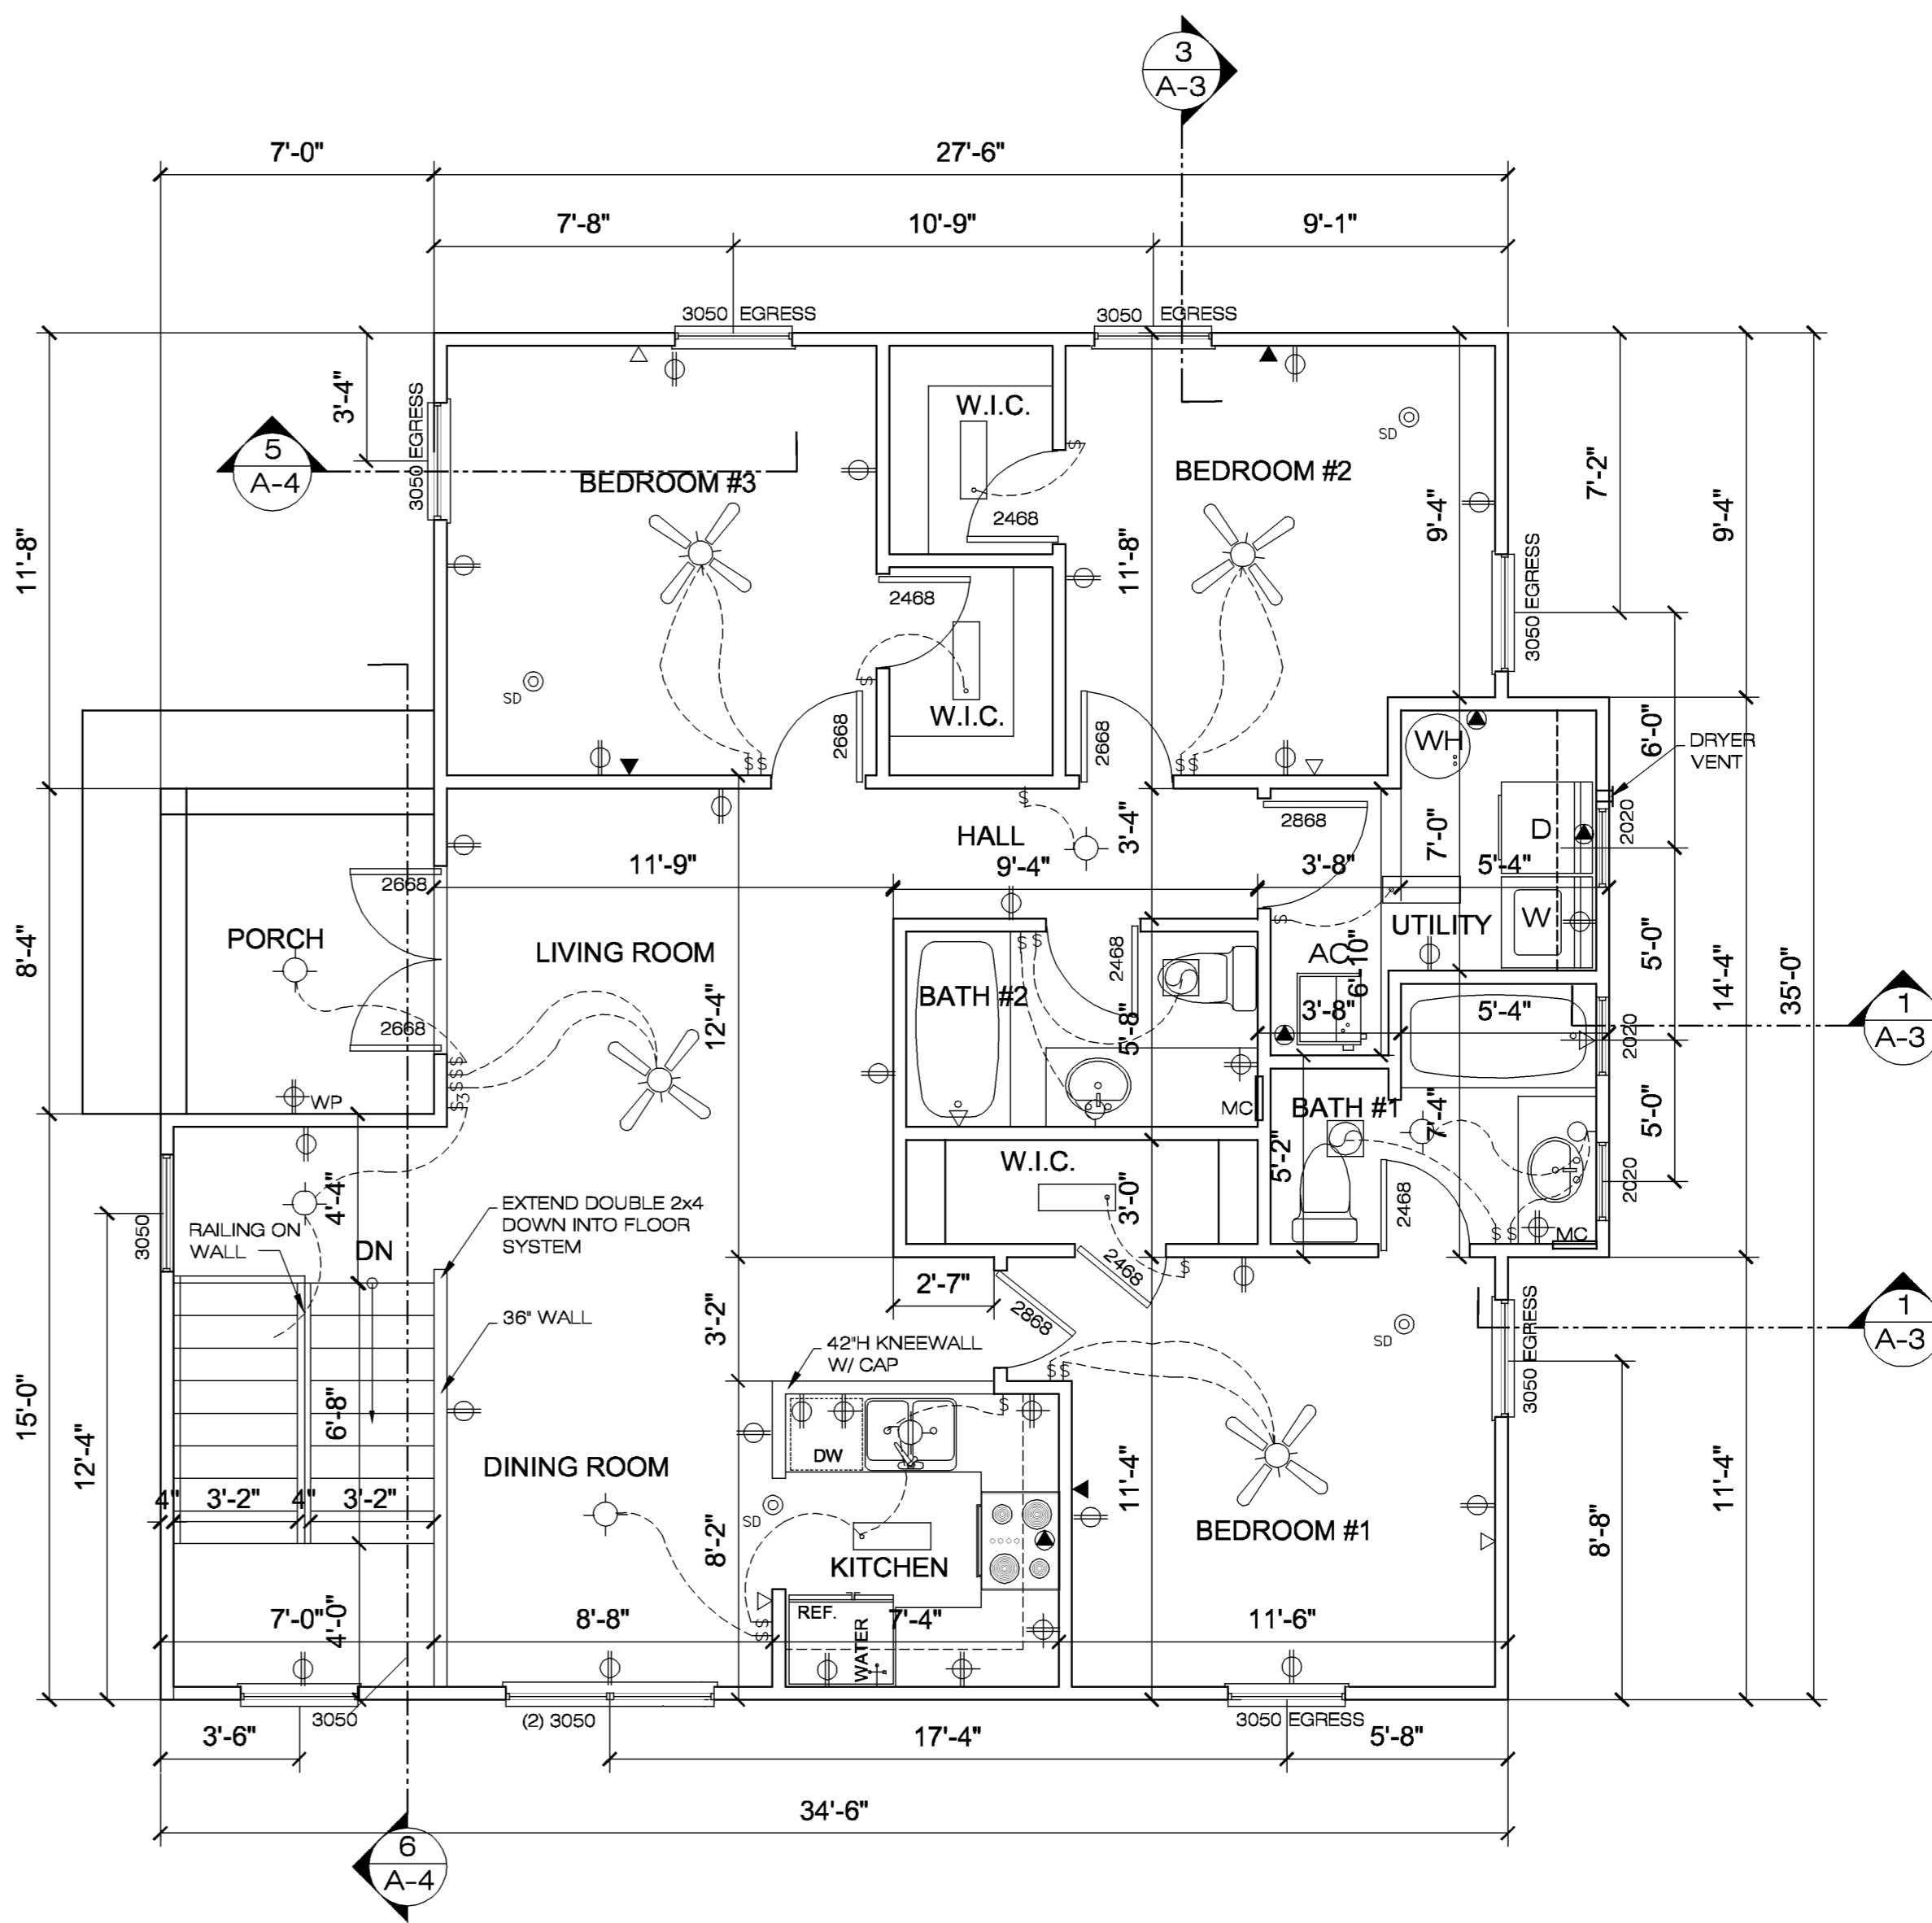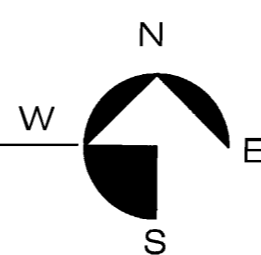

BUILDING #1 - SECOND FLOOR PLAN W/ ELECTRICAL

SCALE: 1/8" = 1'-0"

